
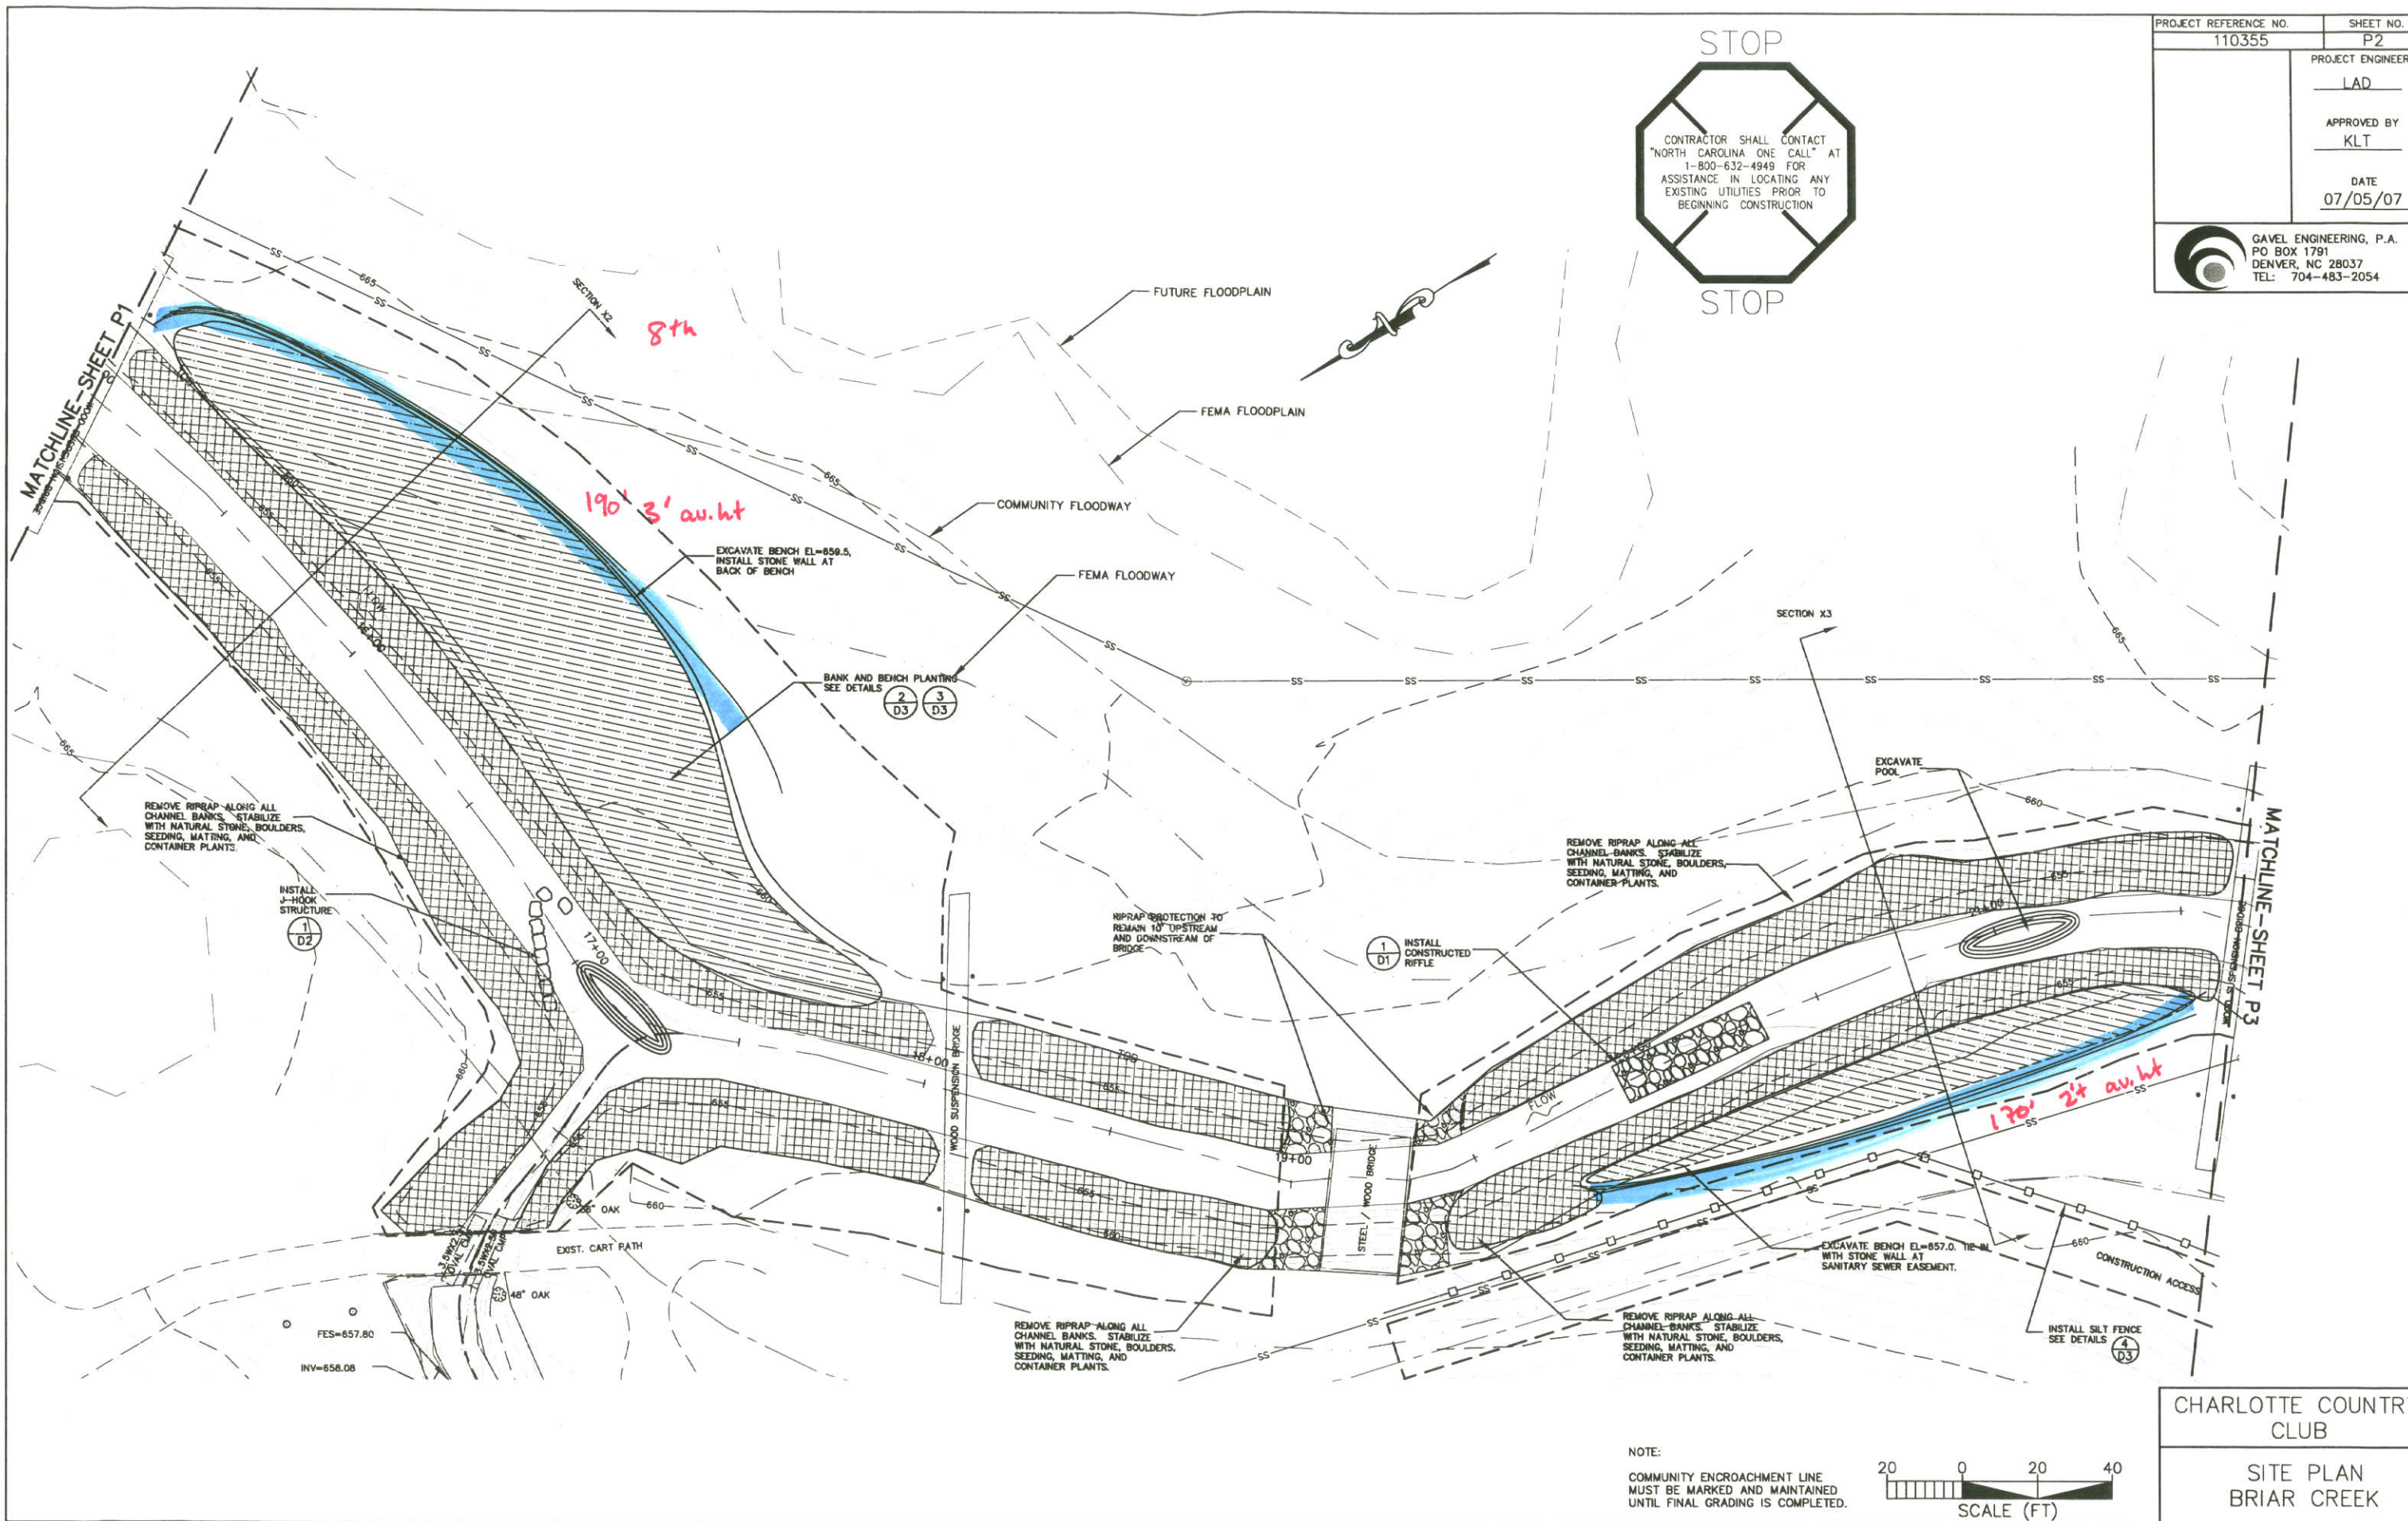
 


PROJECT REFERENCE NO. 110355	SHEET NO. P2
PROJECT ENGINEER LAD	
APPROVED BY KLT	
DATE 07/05/07	
 GAVEL ENGINEERING, P.A. PO BOX 1791 DENVER, NC 28037 TEL: 704-483-2054	



NOTE:
COMMUNITY ENCROACHMENT LINE
MUST BE MARKED AND MAINTAINED
UNTIL FINAL GRADING IS COMPLETED.



CHARLOTTE COUNTRY CLUB
SITE PLAN
BRIAR CREEK